

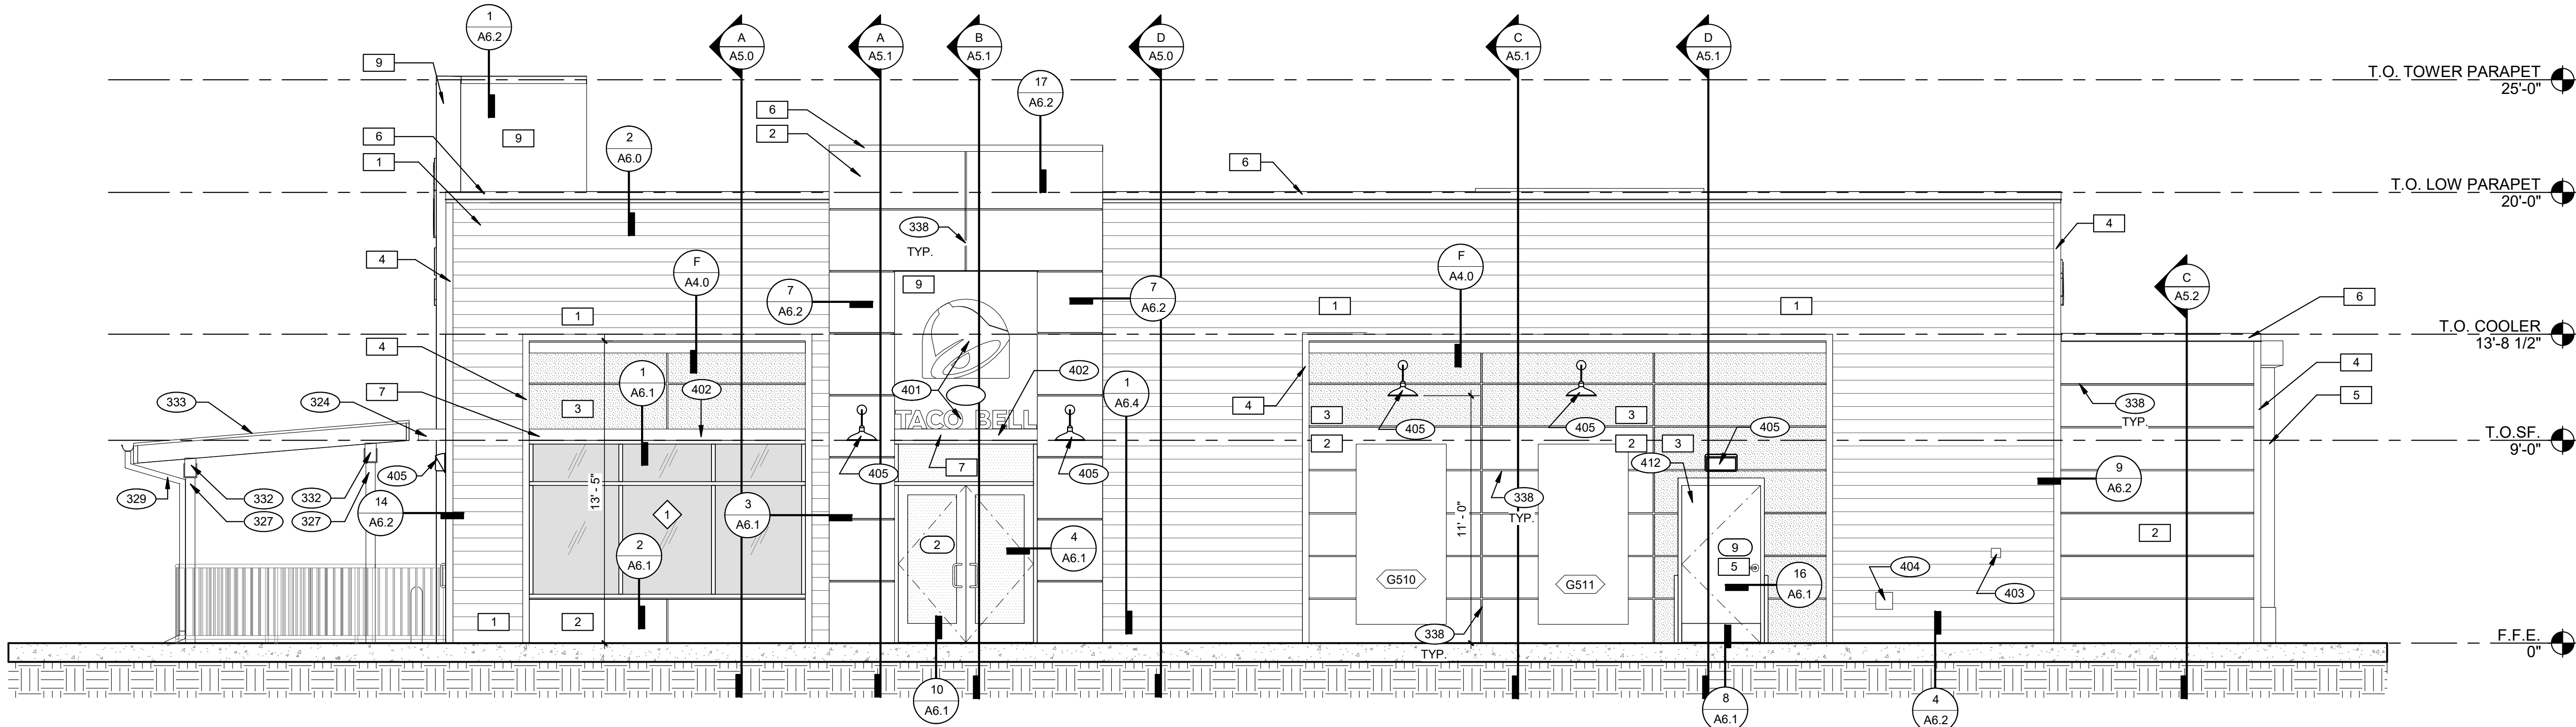


05.19.22

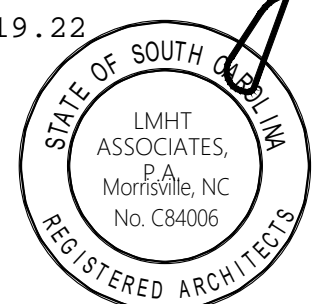

ELEVATION - RIGHT

A

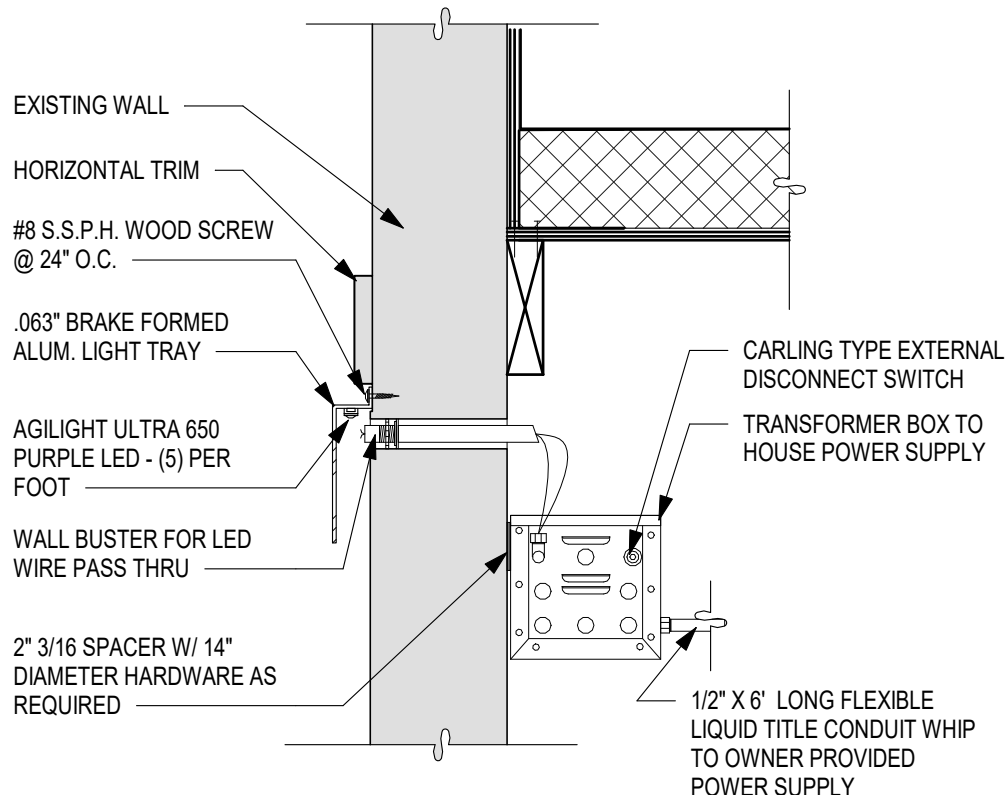

LED WALL WASHER DETAIL

F

TYPE MARK	QTY	ITEM DESCRIPTION	LOC.
TOWER			
V-09.14W	2	14" WHITE CHANNEL LETTERS VERTICAL	A4.1
SIDE ENTRY			
V-04.42	2	42" SWINGING BELL PURPLE LOGO FACE LIT	A4.1
V-200.EN	1	SIDE ENTRY AWNING 6' 4" X 6' 3" BLACK	A4.0
DRIVE THRU			
V-101.DT	1	DT AWNING (OVER DT) 9' 0" X 4' 0" BLACK	A4.1
EYEBROW AWNINGS			
V-202.EN	1	FRONT EYEBROW (WINDOW) 16' 7" X 6' H X 1' 4" D BLACK	A4.1
V-203.EN	1	DT EYEBROW (WINDOW) 7' 8" L X 6' H X 1' 4" D BLACK	A4.1
V-201.EN	1	SIDE ENTRY EYEBROW (WINDOW) 12' L 6' H X 1' 4" D BLACK	A4.0

SIGNAGE

E

MISCELLANEOUS
A. SEE SHEET A1.1 "WINDOW TYPES" FOR WINDOW/STOREFRONT

SEALERS (REFER TO SPECS)
A. SEALANT AT ALL WALL AND ROOF PENETRATIONS.
B. SEALANT AT ALL WINDOW AND DOOR FRAMES AND JAMB. DO NOT SEAL SILL @ WINDOWS.
C. APPLY NEOPRENE GASKET (CONT.) BETWEEN BUILDING AND CANOPY.

CRITICAL DIMENSIONS
A. REQUIRED CLEAR OPENING WIDTH TO ENSURE COORDINATION WITH STANDARD SIGNAGE/BUILDING ELEMENTS DIMENSIONS.

NOTE: NO EXTERIOR SIGNS ARE WITHIN THE SCOPE OF WORK COVERED BY THE BUILDING PERMIT APPLICATION. THE GENERAL CONTRACTOR SHALL BE RESPONSIBLE FOR COORDINATING THE INSTALLATION OF ALL EXTERIOR SIGNS AND INSTALLATION OF REQUIRED BLOCKING AND ELECTRICAL CONNECTIONS FOR FINAL APPROVED SIGNS.

GENERAL NOTES

D

- 324 METAL AWNING FRAMED BY OTHERS. G.C TO PROVIDE AND INSTALL STANDING SEAM
- 327 PATIO COLUMNS. SEE STRUCTURAL DRAWINGS
- 329 PREFINISHED GUTTER AND DOWNSPOUTS
- 332 PATIO ROOF BEAM - REFER TO STRUCTURAL DRAWINGS
- 333 PATIO ROOF - REFER TO EXTERIOR ELEVATIONS FOR FINISHES
- 338 REVEAL; PROVIDE COMPONENTS BY PANEL MFR.
- 401 BUILDING SIGN BY VENDOR. REQUIRES ELECTRICAL. SEE ELECTRICAL PLANS.
- 402 METAL CANOPIES BY VENDOR. REQUIRES ELECTRICAL; SEE ELECTRICAL PLANS.
- 403 CO2 FILLER VALVE & COVER. SEE DET. 17/A6.1.
- 404 HOSE BIB BOX AT 18" A.F.F., SEE DET. 12/A6.1
- 405 EXTERIOR LIGHT FIXTURE. SEE ELECTRICAL DRAWINGS
- 412 SERVICE DOOR.

no structural drawings

KEY NOTES

CONTRACT DATE: 03/31/2022
BUILDING TYPE: END. MED 40
PLAN VERSION: SEPT. 2021
BRAND DESIGNER:
SITE NUMBER: 315669
ENTITY NUMBER: 458169
PA/PM:
DRAWN BY: :
JOB NO.: 22204

ENDEAVOR 2.0
SPEARS CREEK CHURCH RD
(BY LIBERTY RIDGE DRIVE)
SOUTH CAROLINA 29229



ENDEAVOR 2.0
EXTERIOR
ELEVATIONS

A4.0

PLOT DATE: 5/18/2022 5:28:04 PM

EXTERIOR FINISH SCHEDULE					
MARK	ITEM/MATERIAL	MANUFACTURER	MATERIAL SPEC	COLOR	CONTACT INFO.
1	CEMENT FIBER BOARD LAP SIDING	JAMES HARDIE	ARTISAN SMOOTH LAP SIDING 7"	FACTORY PRIMED; PAINTED SW7043 WORLDLY GRAY	http://www.artisanluxury.com/
2	CEMENT FIBER PANEL SYSTEM - CYBERSPACE	JAMES HARDIE	REVEAL PANEL SYSTEM	FACTORY PRIMED; PAINTED SW7076 CYBERSPACE	http://www.jameshardie.com/Product/s/HardiePanel-Vertical-Siding
3	CEMENT FIBER PANEL SYSTEM - PURPLE	JAMES HARDIE	REVEAL PANEL SYSTEM	FACTORY PRIMED; PAINTED TB 2603C	http://www.jameshardie.com/Product/s/HardiePanel-Vertical-Siding
4	CEMENT FIBER BOARD TRIM	JAMES HARDIE	HARDIE TRIM, 1X4	PAINTED, CYBERSPACE (SW7076), SMOOTH FINISH	SEE C/A7.2
5	<varies>			COLOR TO MATCH WALL BEHIND	
6	METAL PARAPET COPING		24 GA. GALVANIZED	CYBERSPACE (SW7076) KYNAR 500 COATING	
7	AWNINGS	SIGNAGE VENDOR		BLACK, BY THE SIGNAGE VENDOR	
8	BOLLARD	STREET SMART		YELLOW - 1/4" THICK PLASTIC COVER (USPOSTMAN.COM) OR EQUAL	
9	CORNER TOWER	WESTERN STATE	T-GROOVE 24 GA PAINTED 18" PANEL	WEATHERED RUSTIC	

EXTERIOR FINISH SCHEDULE

G

ARTWORK SCHEDULE				
TAG	NAME	FRAME OR MURAL	SIZE	LOCATION IN RESTAURANT
G-280	G-280-B-F01-2 8X40	FRAMED ART	OVERLAP BELLS	INTERIOR - ENTRY WALL
G-281	G-281-B-F01-2 8X40	FRAMED ART	OVERLAP BELLS	INTERIOR - ENTRY WALL
G-282	G-282-B-F01-2 8X40	FRAMED ART	OVERLAP BELLS	INTERIOR - ENTRY WALL
G-510	G-510-B-M02-CUSTOM SIZE	MURAL - EXTERIOR	CAMO PATTERN - PURPLE (EXTERIOR)	FACADE
G-511	G-511-B-M02-CUSTOM SIZE	MURAL - EXTERIOR	CAMO PATTERN - PURPLE (EXTERIOR)	FACADE
G-511	G-511-B-M02-CUSTOM SIZE	MURAL - EXTERIOR	CAMO PATTERN - PURPLE (EXTERIOR)	FACADE - DRIVE THRU
G-512	G-512-B-M02-CUSTOM SIZE	EXPRESSION PANEL	CAMO PATTERN - PURPLE (EXTERIOR)	
G-326	G-326-D-M01-CUSTOM SIZE	MURAL - INTERIOR	CAMO PATTERN - PURPLE	INTERIOR - ADJACENT TO DRINK STATION

ARTWORK SCHEDULE

C

PAINT NOTES

H