



HA\KLV\PESK\DPESKE401 20 Nov 2018 - 3:15 pm

REFER TO CAPTIVE AIRE SUBMITTAL ON SHEET M-404 FOR KITCHEN EXHAUST SYSTEM WIRING DIAGRAM.

KITCHEN EXHAUST SYSTEM DIAGRAM 3  
NOT TO SCALE E-401

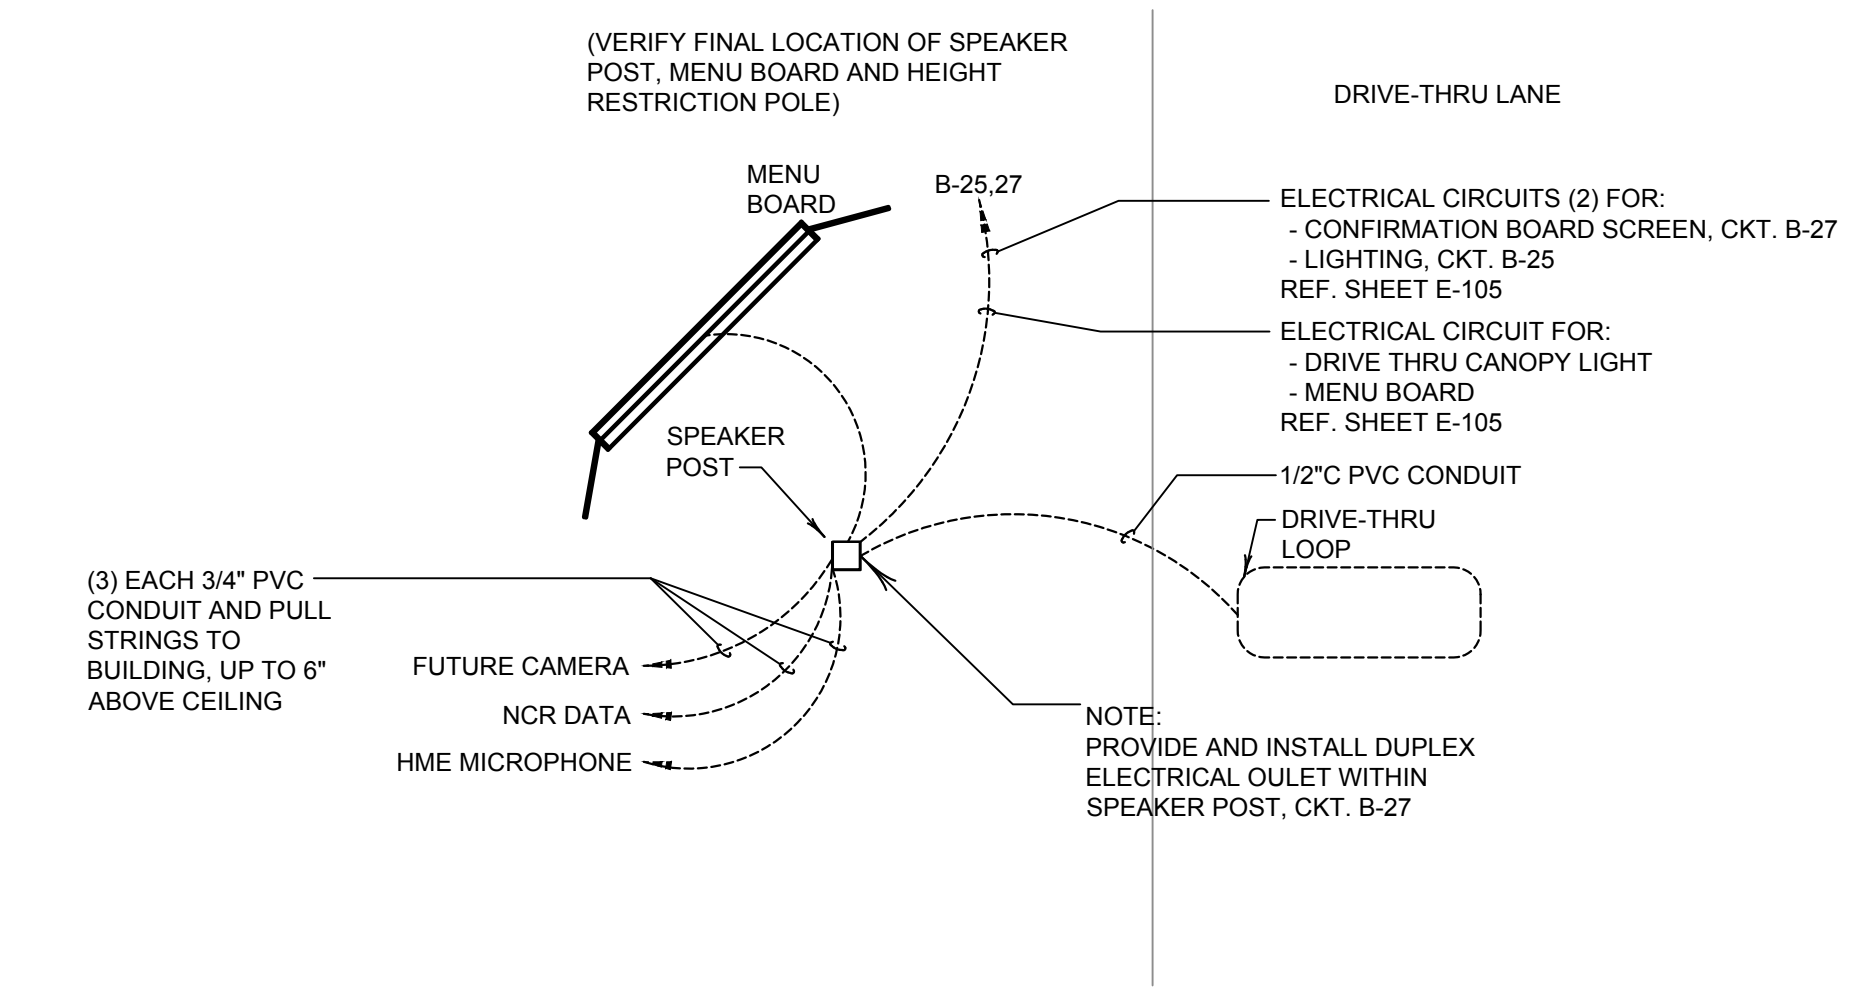

MENU BOARD & SENSOR LOOP 1  
E-401

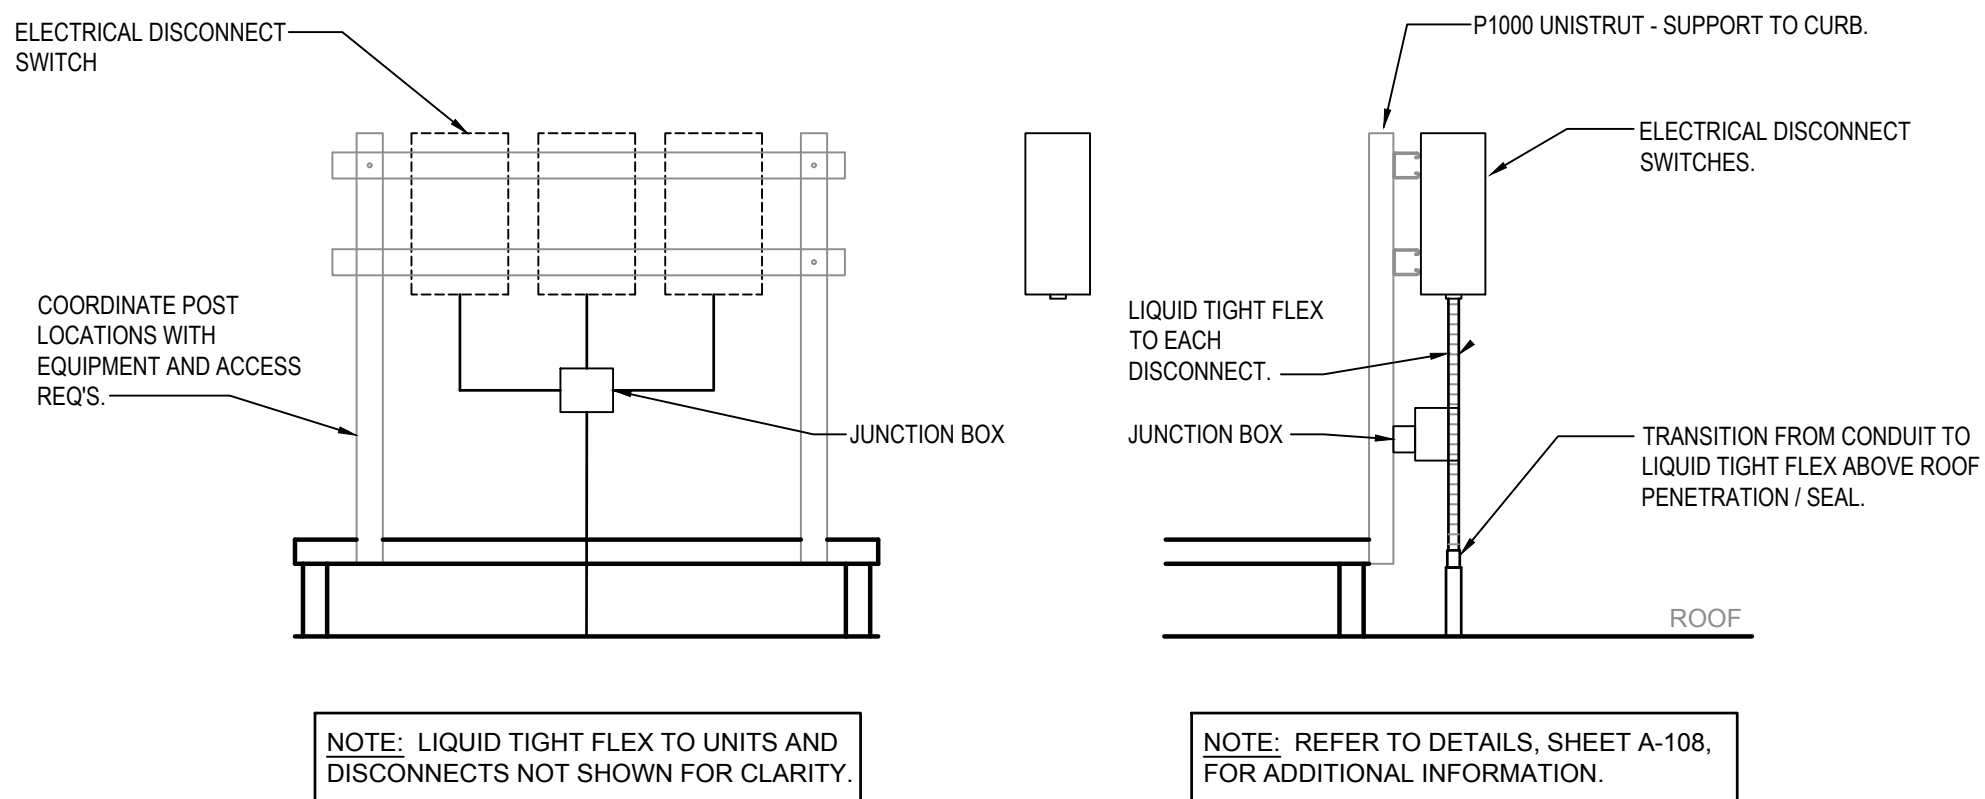

EQUIPMENT DISCONNECT SWITCH SUPPORT 2  
NOT TO SCALE E-401



PANDA EXPRESS INC.  
1683 Walnut Grove Ave.  
Rosemead, California  
91770  
Telephone: 626.799.9898  
Facsimile: 626.372.8288

All ideas, designs, arrangement and plans indicated or represented by this drawing are the property of Panda Express Inc. and were created for use on this specific project. None of these ideas, designs, arrangements or plans may be used by or disclosed to any person, firm, or corporation without the written permission of Panda Express Inc.

REVISIONS:		
ISSUE DATE:		
1ST	PERMIT SET	10-05-18
2ND	BID SET	11-20-18

DRAWN BY: BEN

PANDA PROJECT #: S8-19-D6462  
ARCH PROJECT #: 180044.013



PANDA EXPRESS  
TRUE WARM & WELCOME 2200  
CONESTOGA PKWY & HISTORICAL TRAIL  
SHEPHERDSVILLE, KY 40165

E-401

ELECTRICAL DETAILS, DIAGRAMS

BID SET 11.20.2018